

HARRIMAN


AUBURN PORTLAND PORTSMOUTH BOSTON

CENTRAL MAINE
COMMUNITY COLLEGE
ECE AREA RENOVATION

AUBURN, MAINE


Harriman Project No. 16611

Key Plan Prog North

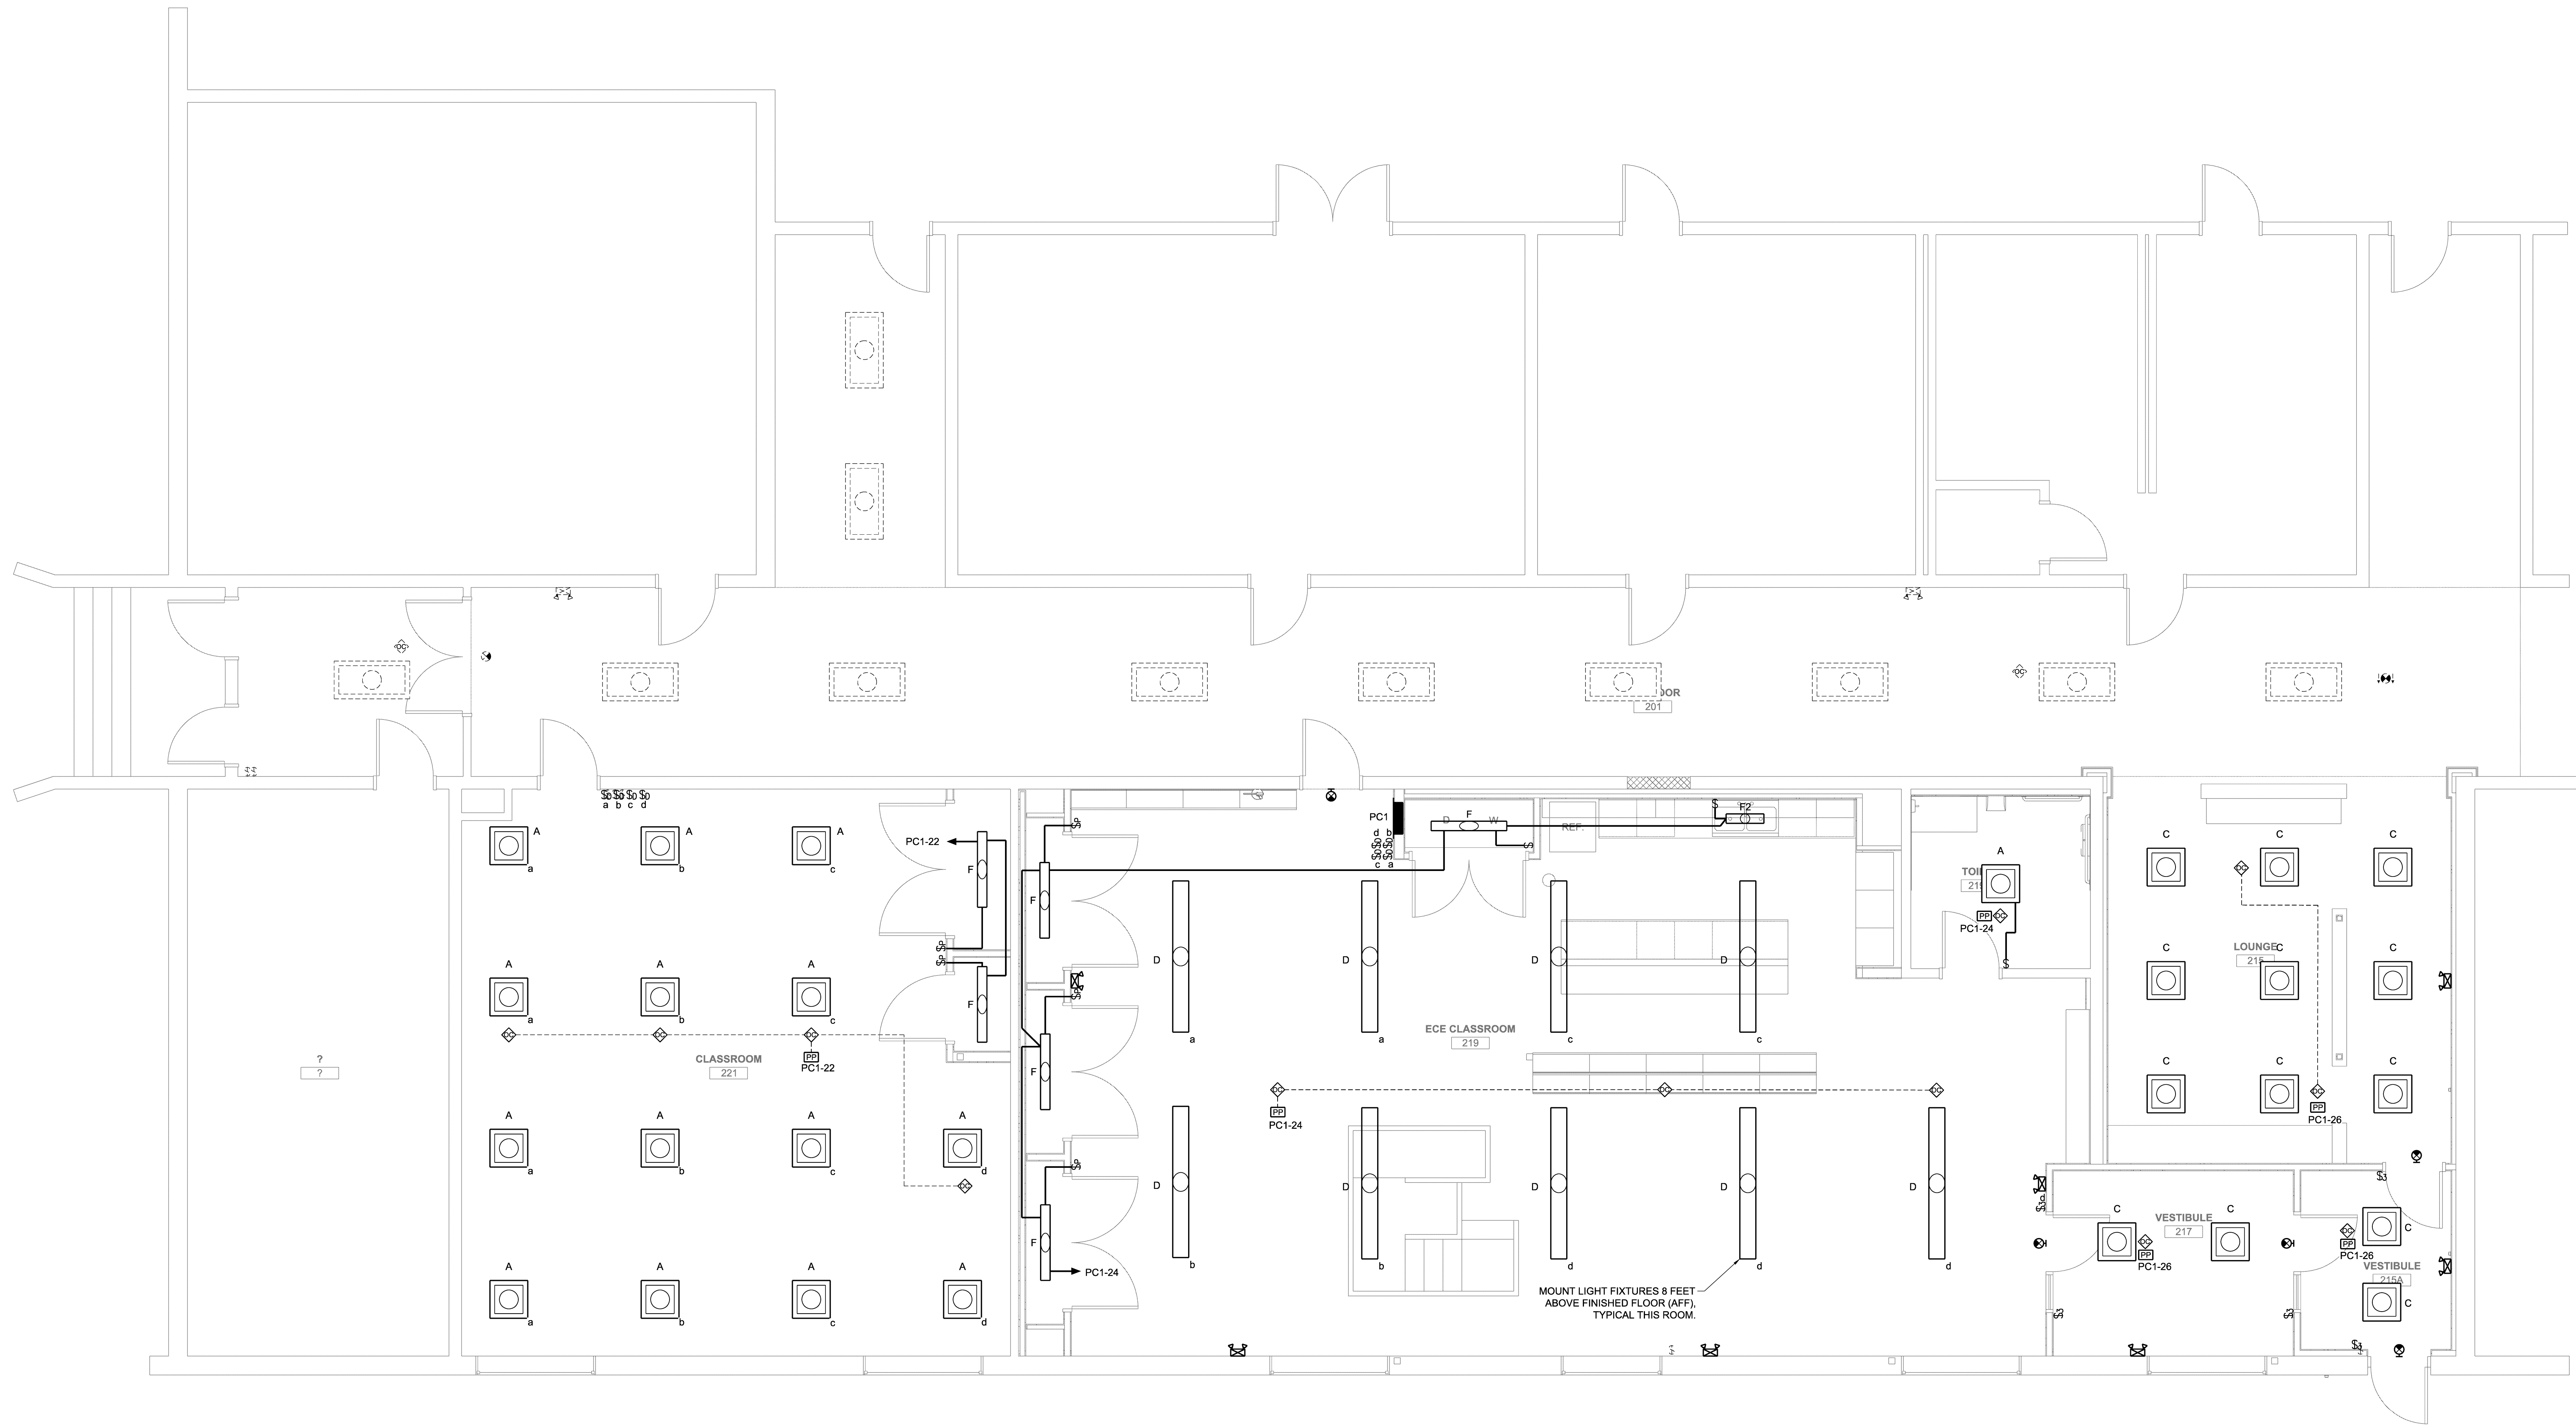

Issues and Revisions

Date	Description
03-29-17	CONSTRUCTION DOCUMENTS

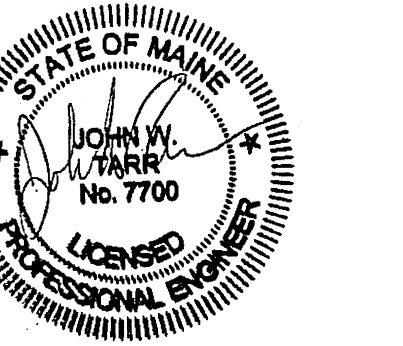

Drawing Scales

PA / PE: JWT © 2017
Drawn By: PRA Harriman Associates

FIRST FLOOR PLAN
LIGHTING

E10.1