




1 BOILER PIPING DIAGRAM
NO SCALE

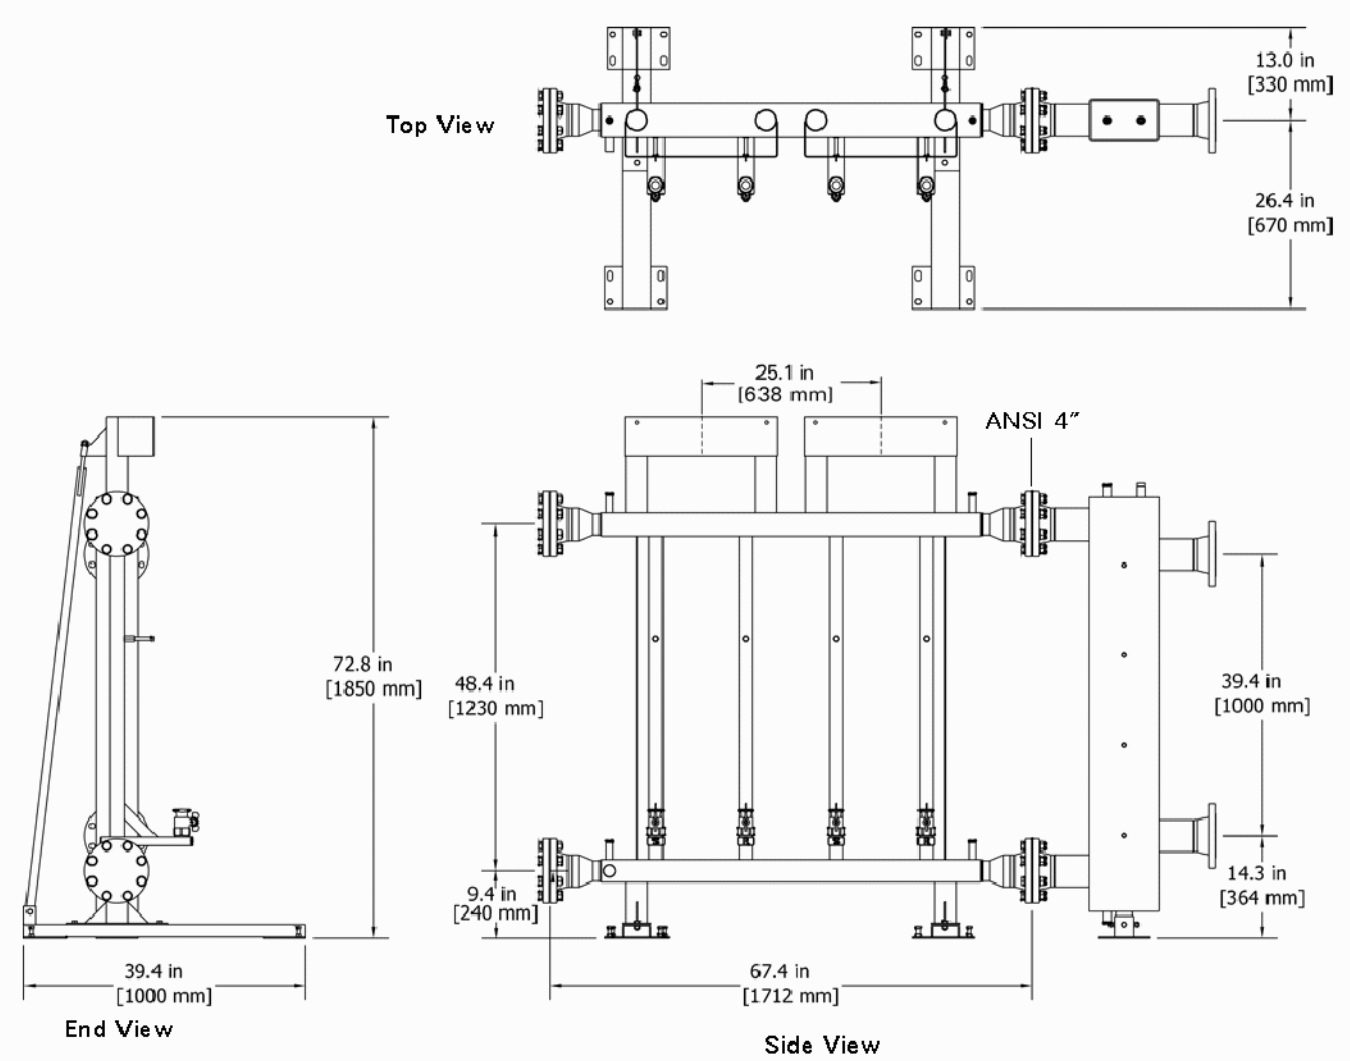


2 BOILER STANDS
NO SCALE

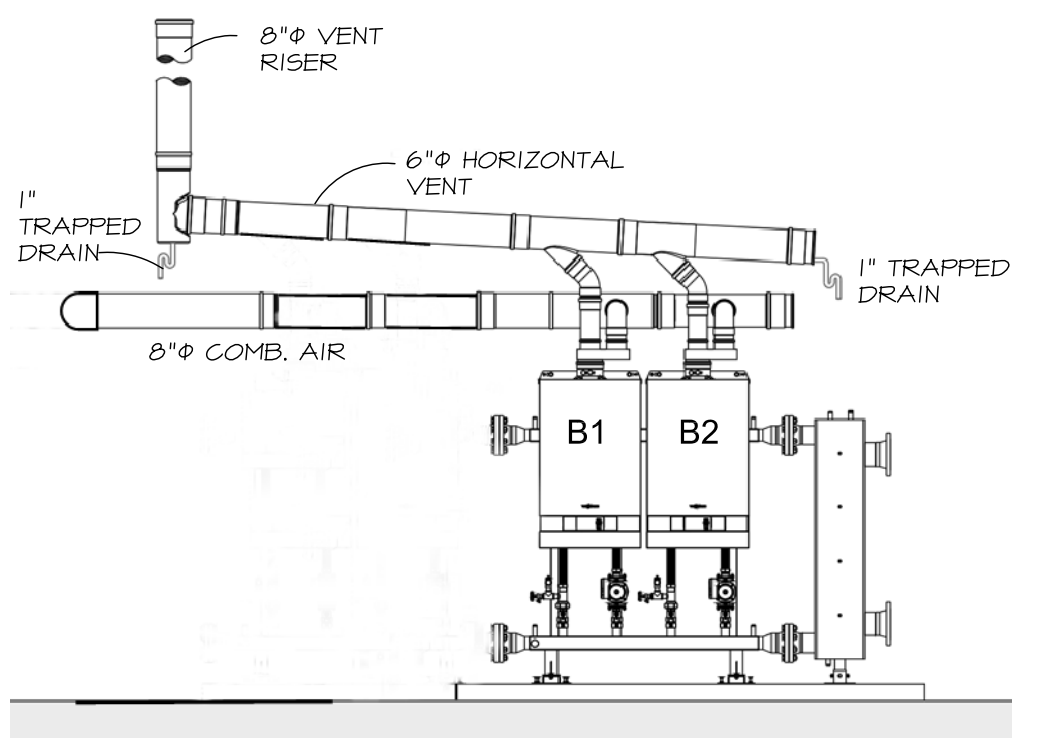


3 BOILER VENTING DIAGRAM
NO SCALE

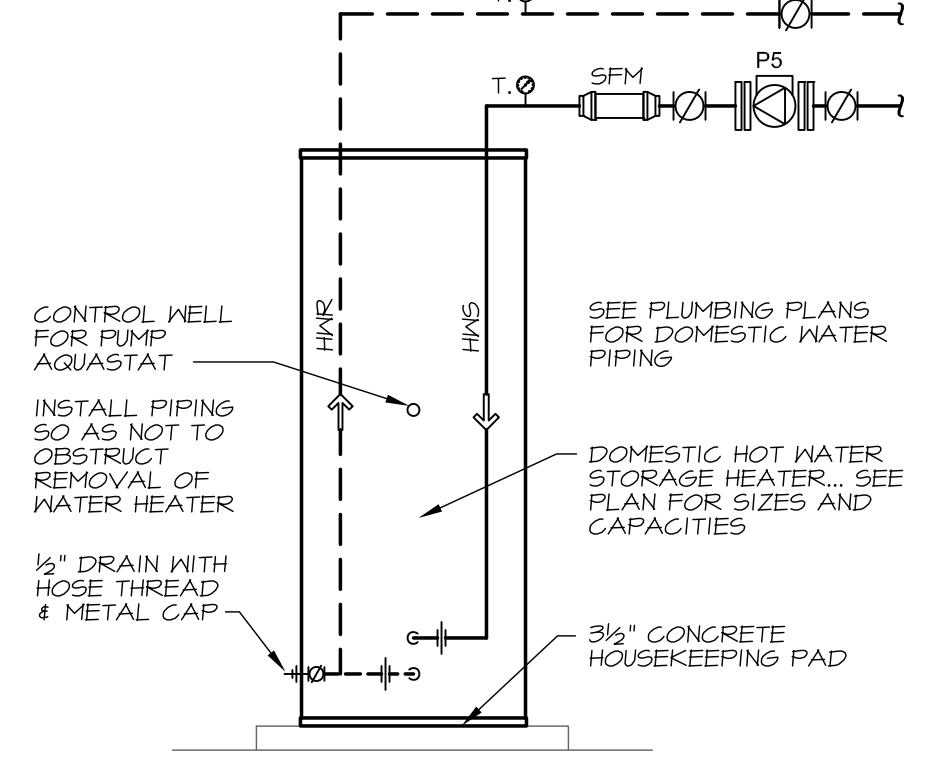


4 STORAGE WATER HEATER DETAIL
NO SCALE

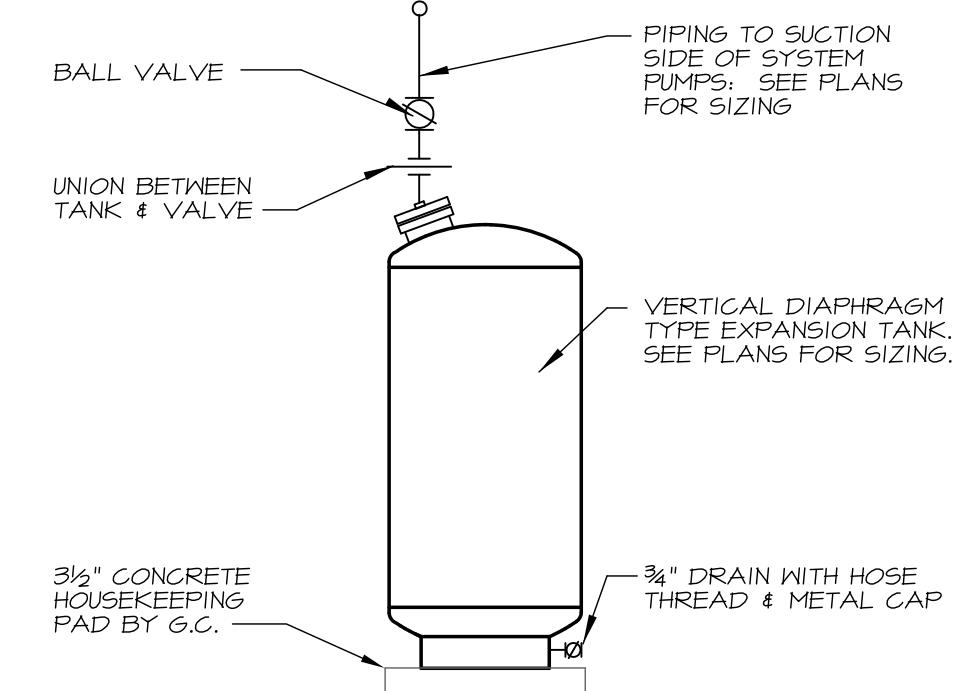


5 DIAPHRAGM TYPE EXPANSION TANK
NO SCALE

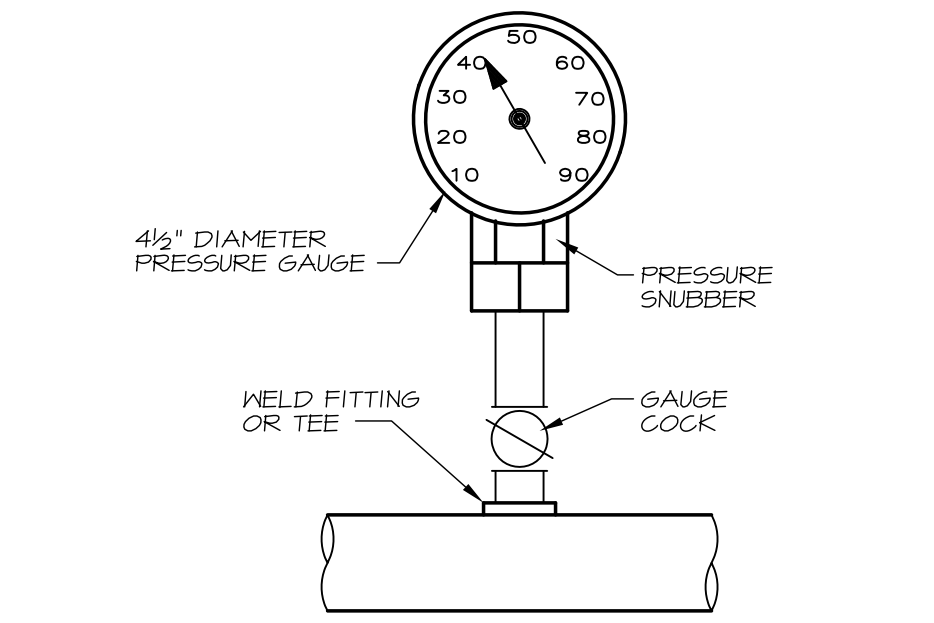


8 WATER PRESSURE GAUGE
NO SCALE

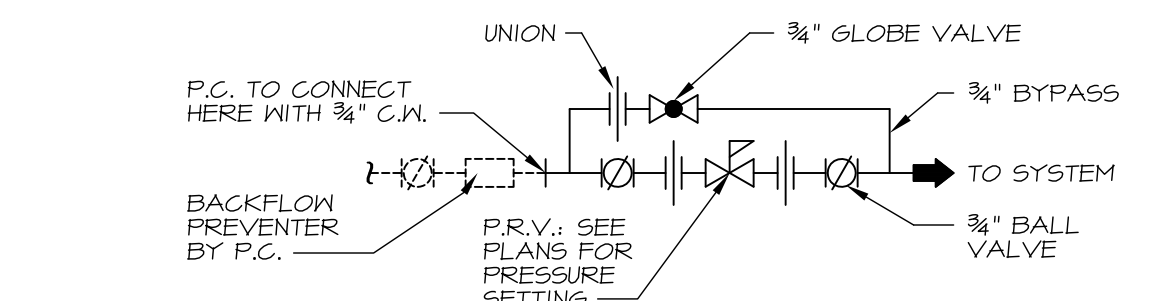


9 HEATING SYSTEM WATER MAKE-UP DETAIL
NO SCALE

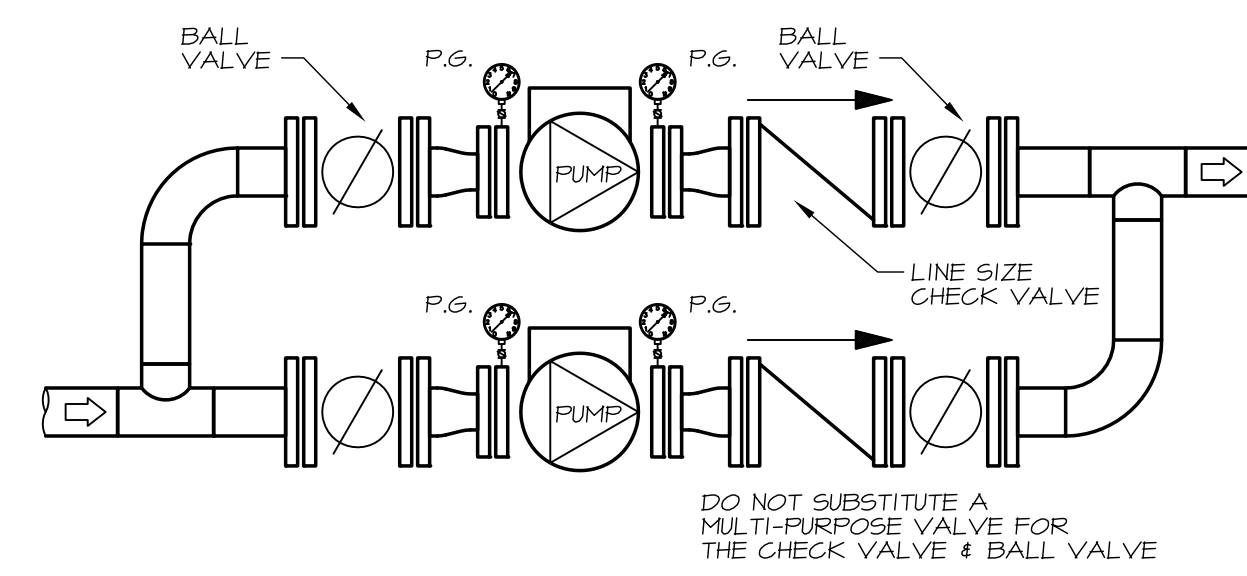


10 CIRCULATING PUMPS PIPING
NO SCALE

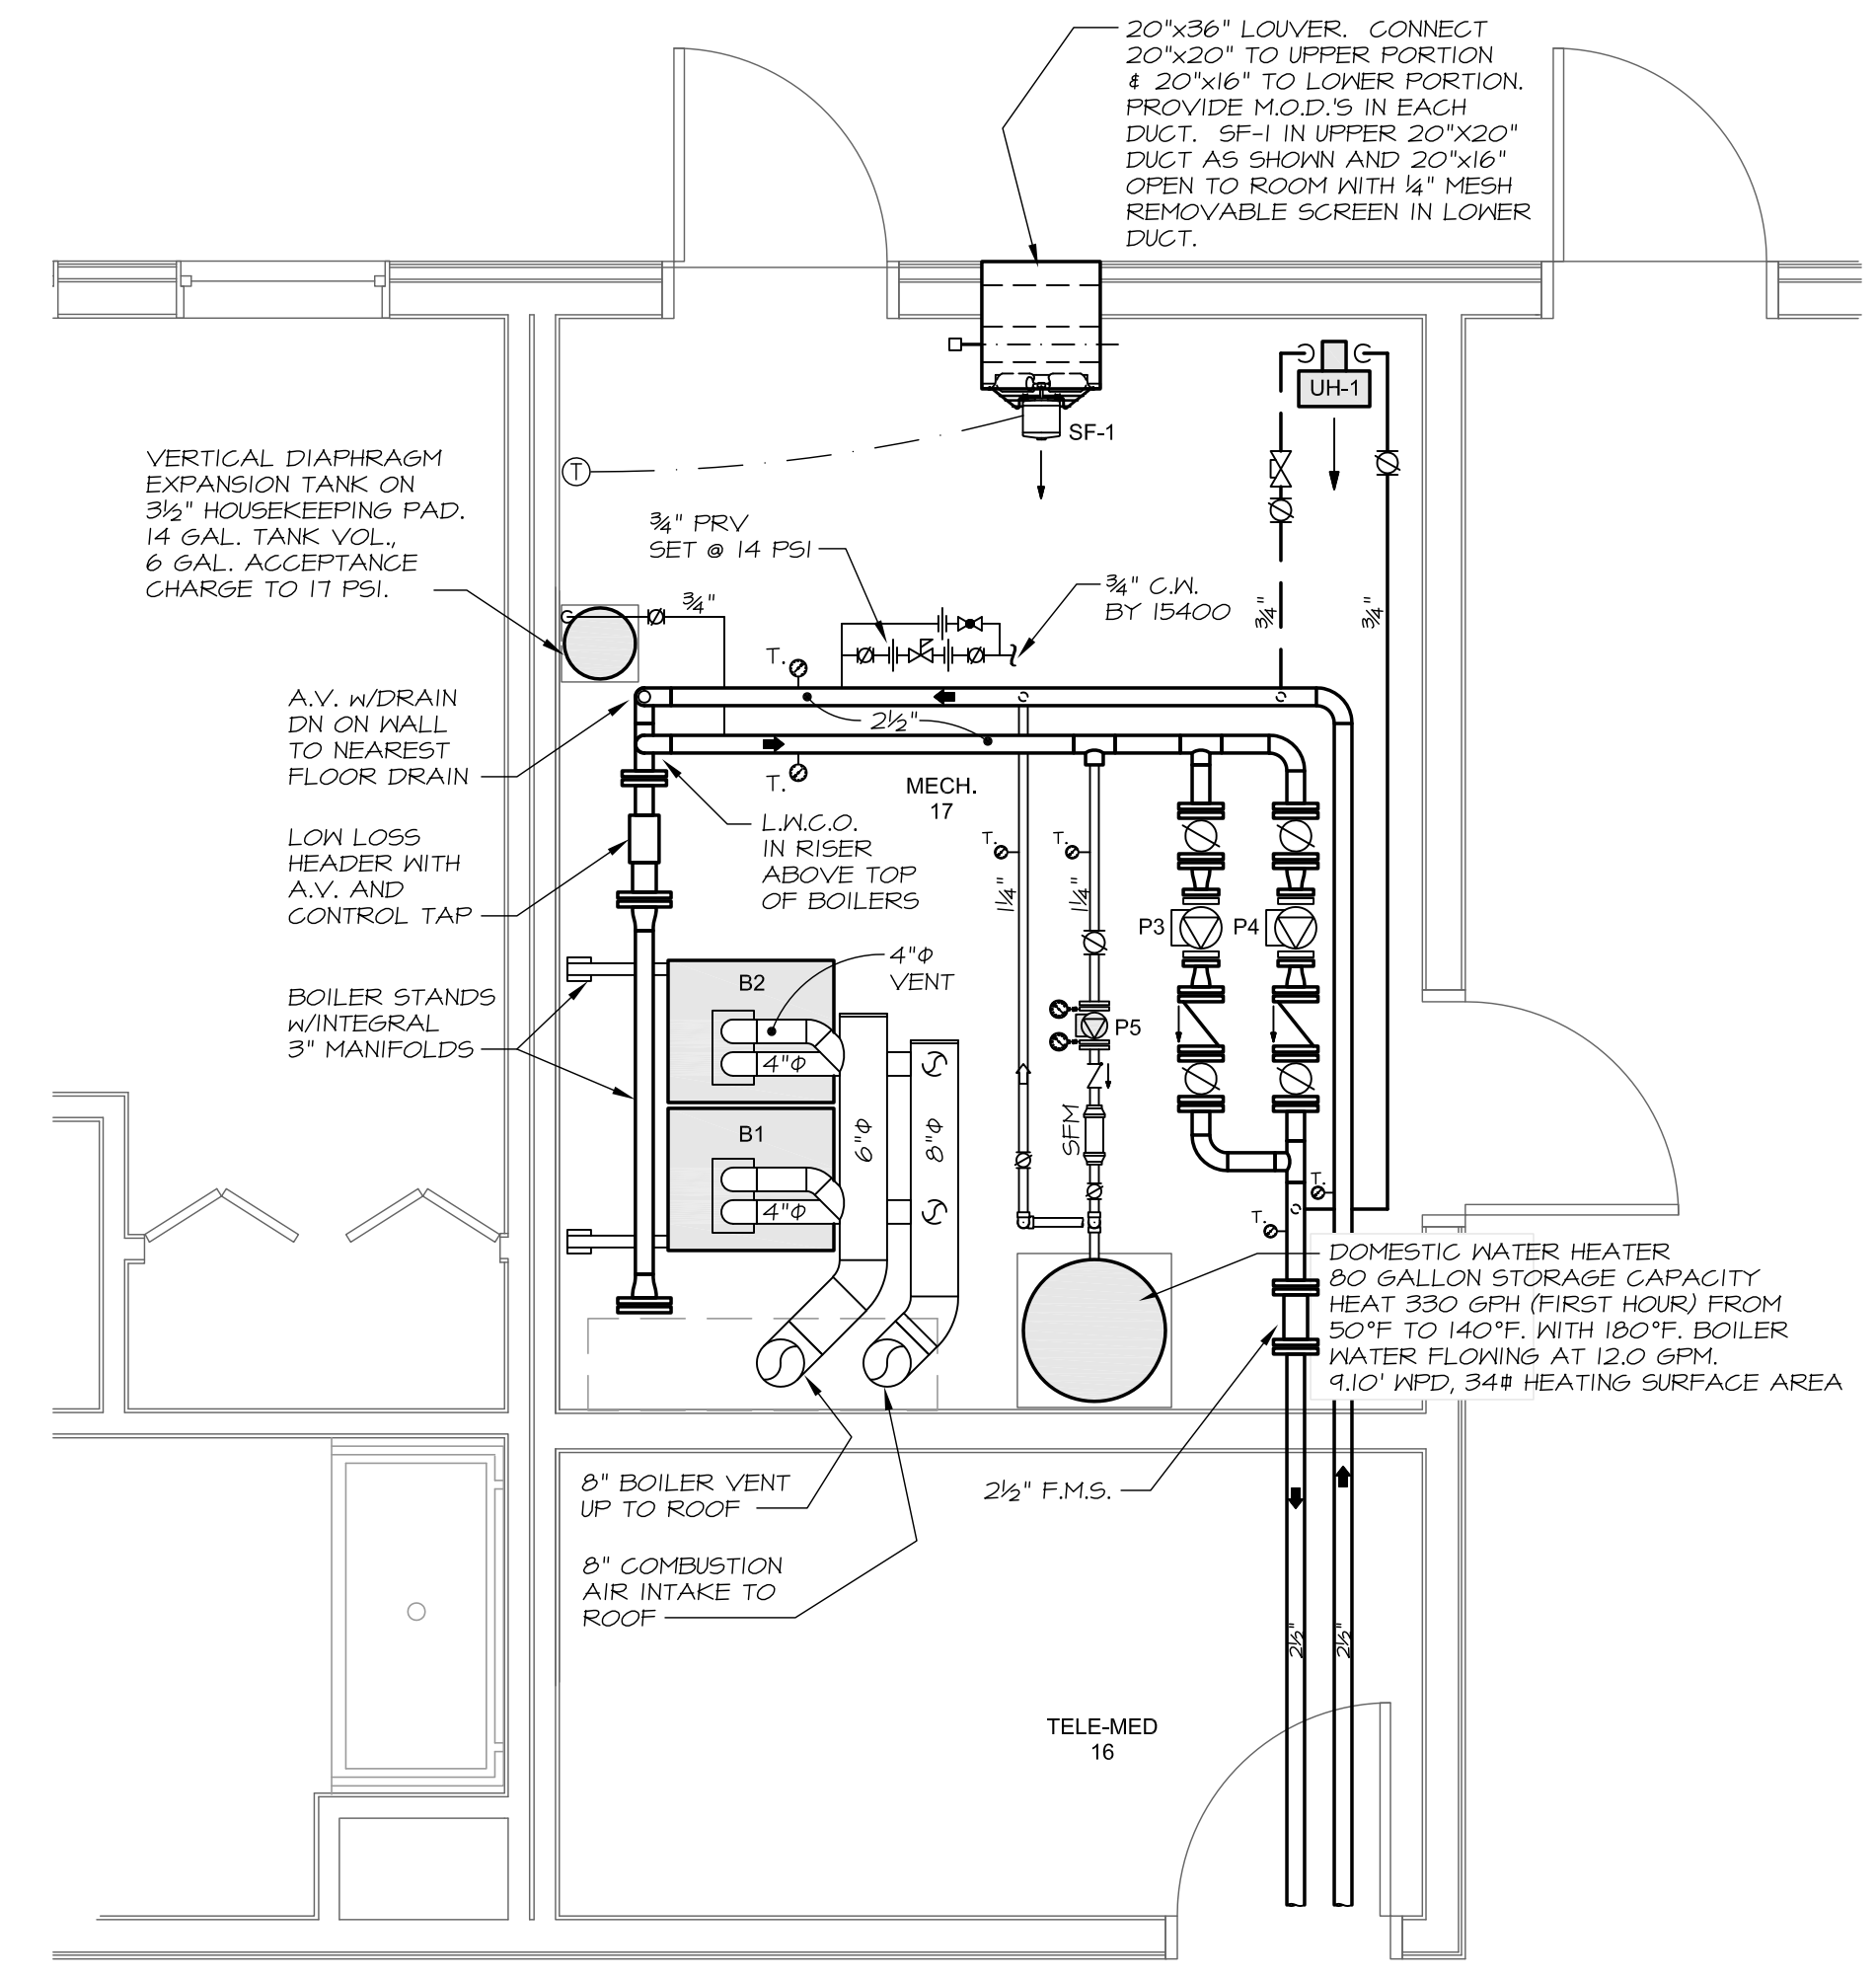


13 MECHANICAL ROOM PLAN
SCALE: 3/8" = 1'-0"

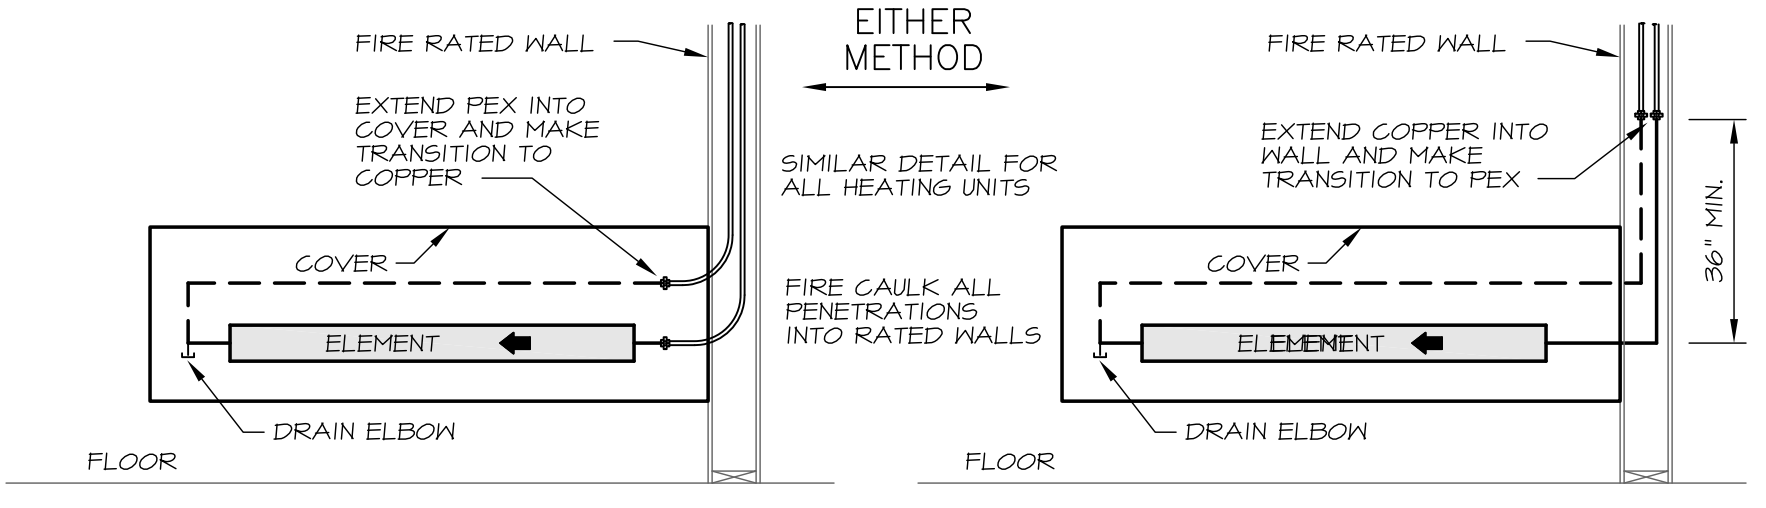


6 DOWNFEED PIPING WITH PIPING IN RATED WALLS
NO SCALE

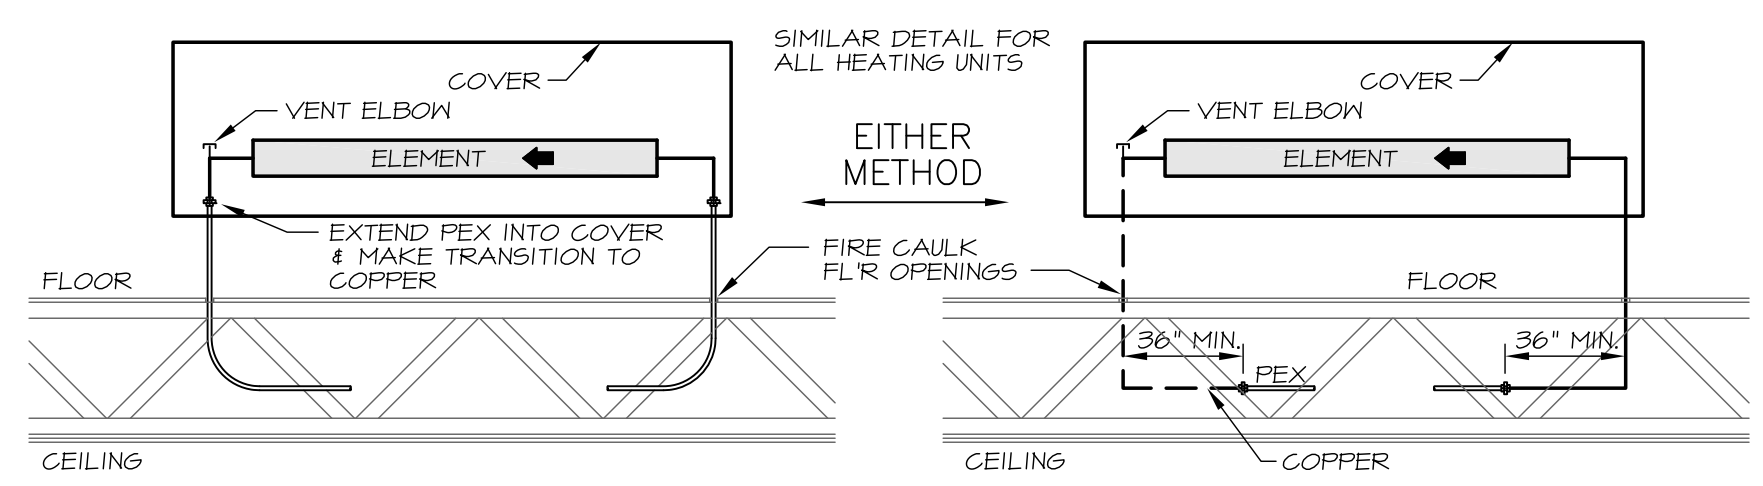


7 UPFEED PIPING THROUGH RATED FLOOR/CEILING
NO SCALE

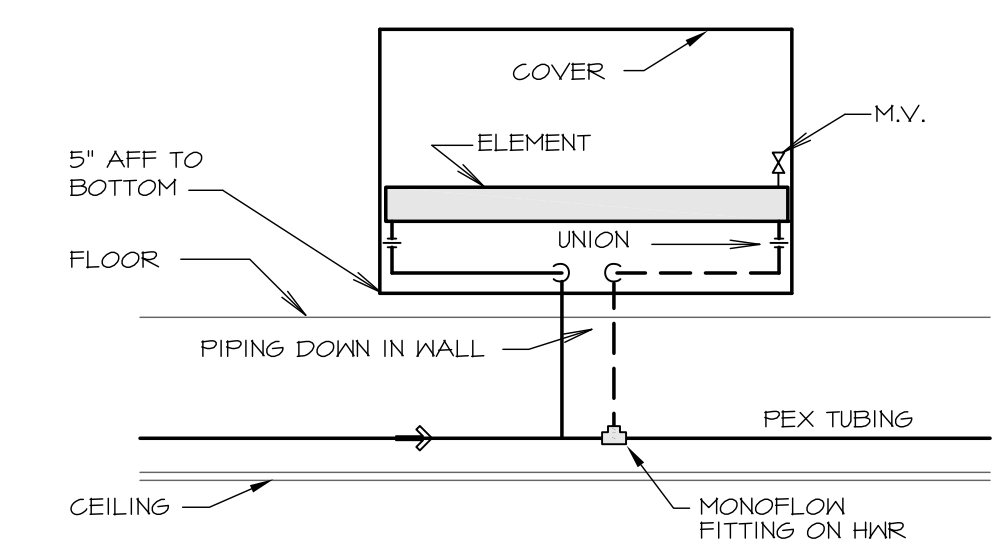


11 UPFEED CONVECTOR
NO SCALE

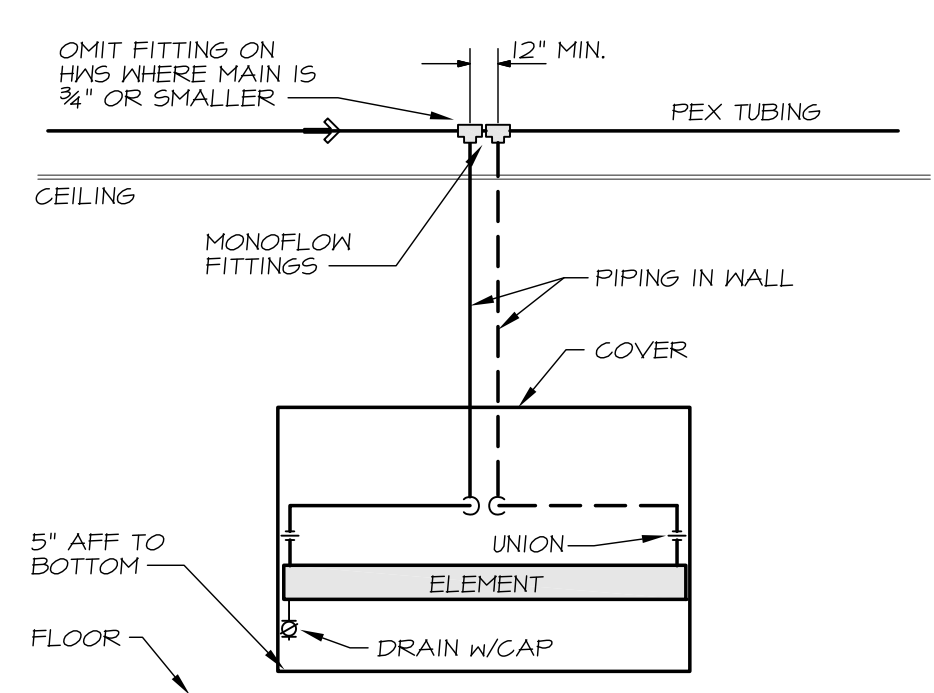

12 DOWNFEED CONVECTOR
NO SCALE

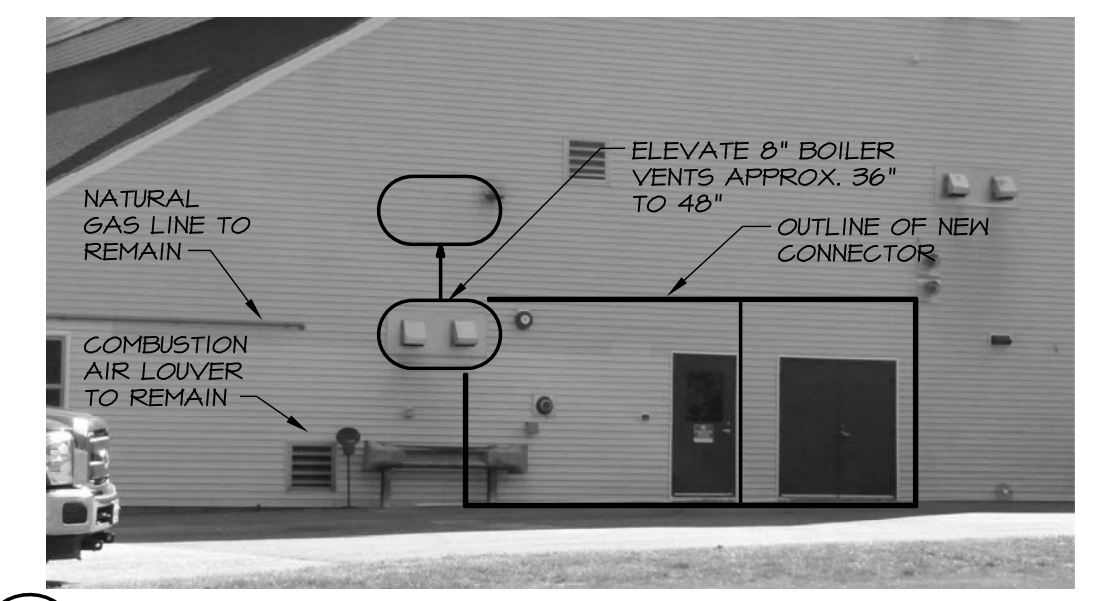

 14 EXISTING BUILDING AT CONNECTOR
NO SCALE



Prepared For: **WESTBROOK HOUSING AUTHORITY**
Westbrook, ME 04330

Consulting Engineer: **MECHANICAL SYSTEMS ENGINEERS**
ROYAL RIVER CENTER, UNIT 10B
10 FOREST FALLS (201) 842-4141
FACEBOOK: MECHANICAL SYSTEMS ENGINEERS © COPYRIGHT 2016

Architect: **ARCHETYPE architects**
48 Union Wharf Portland, Maine 04101
(207) 773-6022 ARCHETYPE@ARCHETYPEPA.COM

Project: **MILLBROOK ESTATES APARTMENTS**
1-04-2016 Bid Set

Revisions: **MECHANICAL ROOM PLAN AND GENERAL MECHANICAL DETAILS**

Date: **04 JAN. 2016** Scale: **3/8" = 1'-0"**

MSE PROJECT 1513