



1 SECOND FLOOR POWER
1/8" = 1'-0"

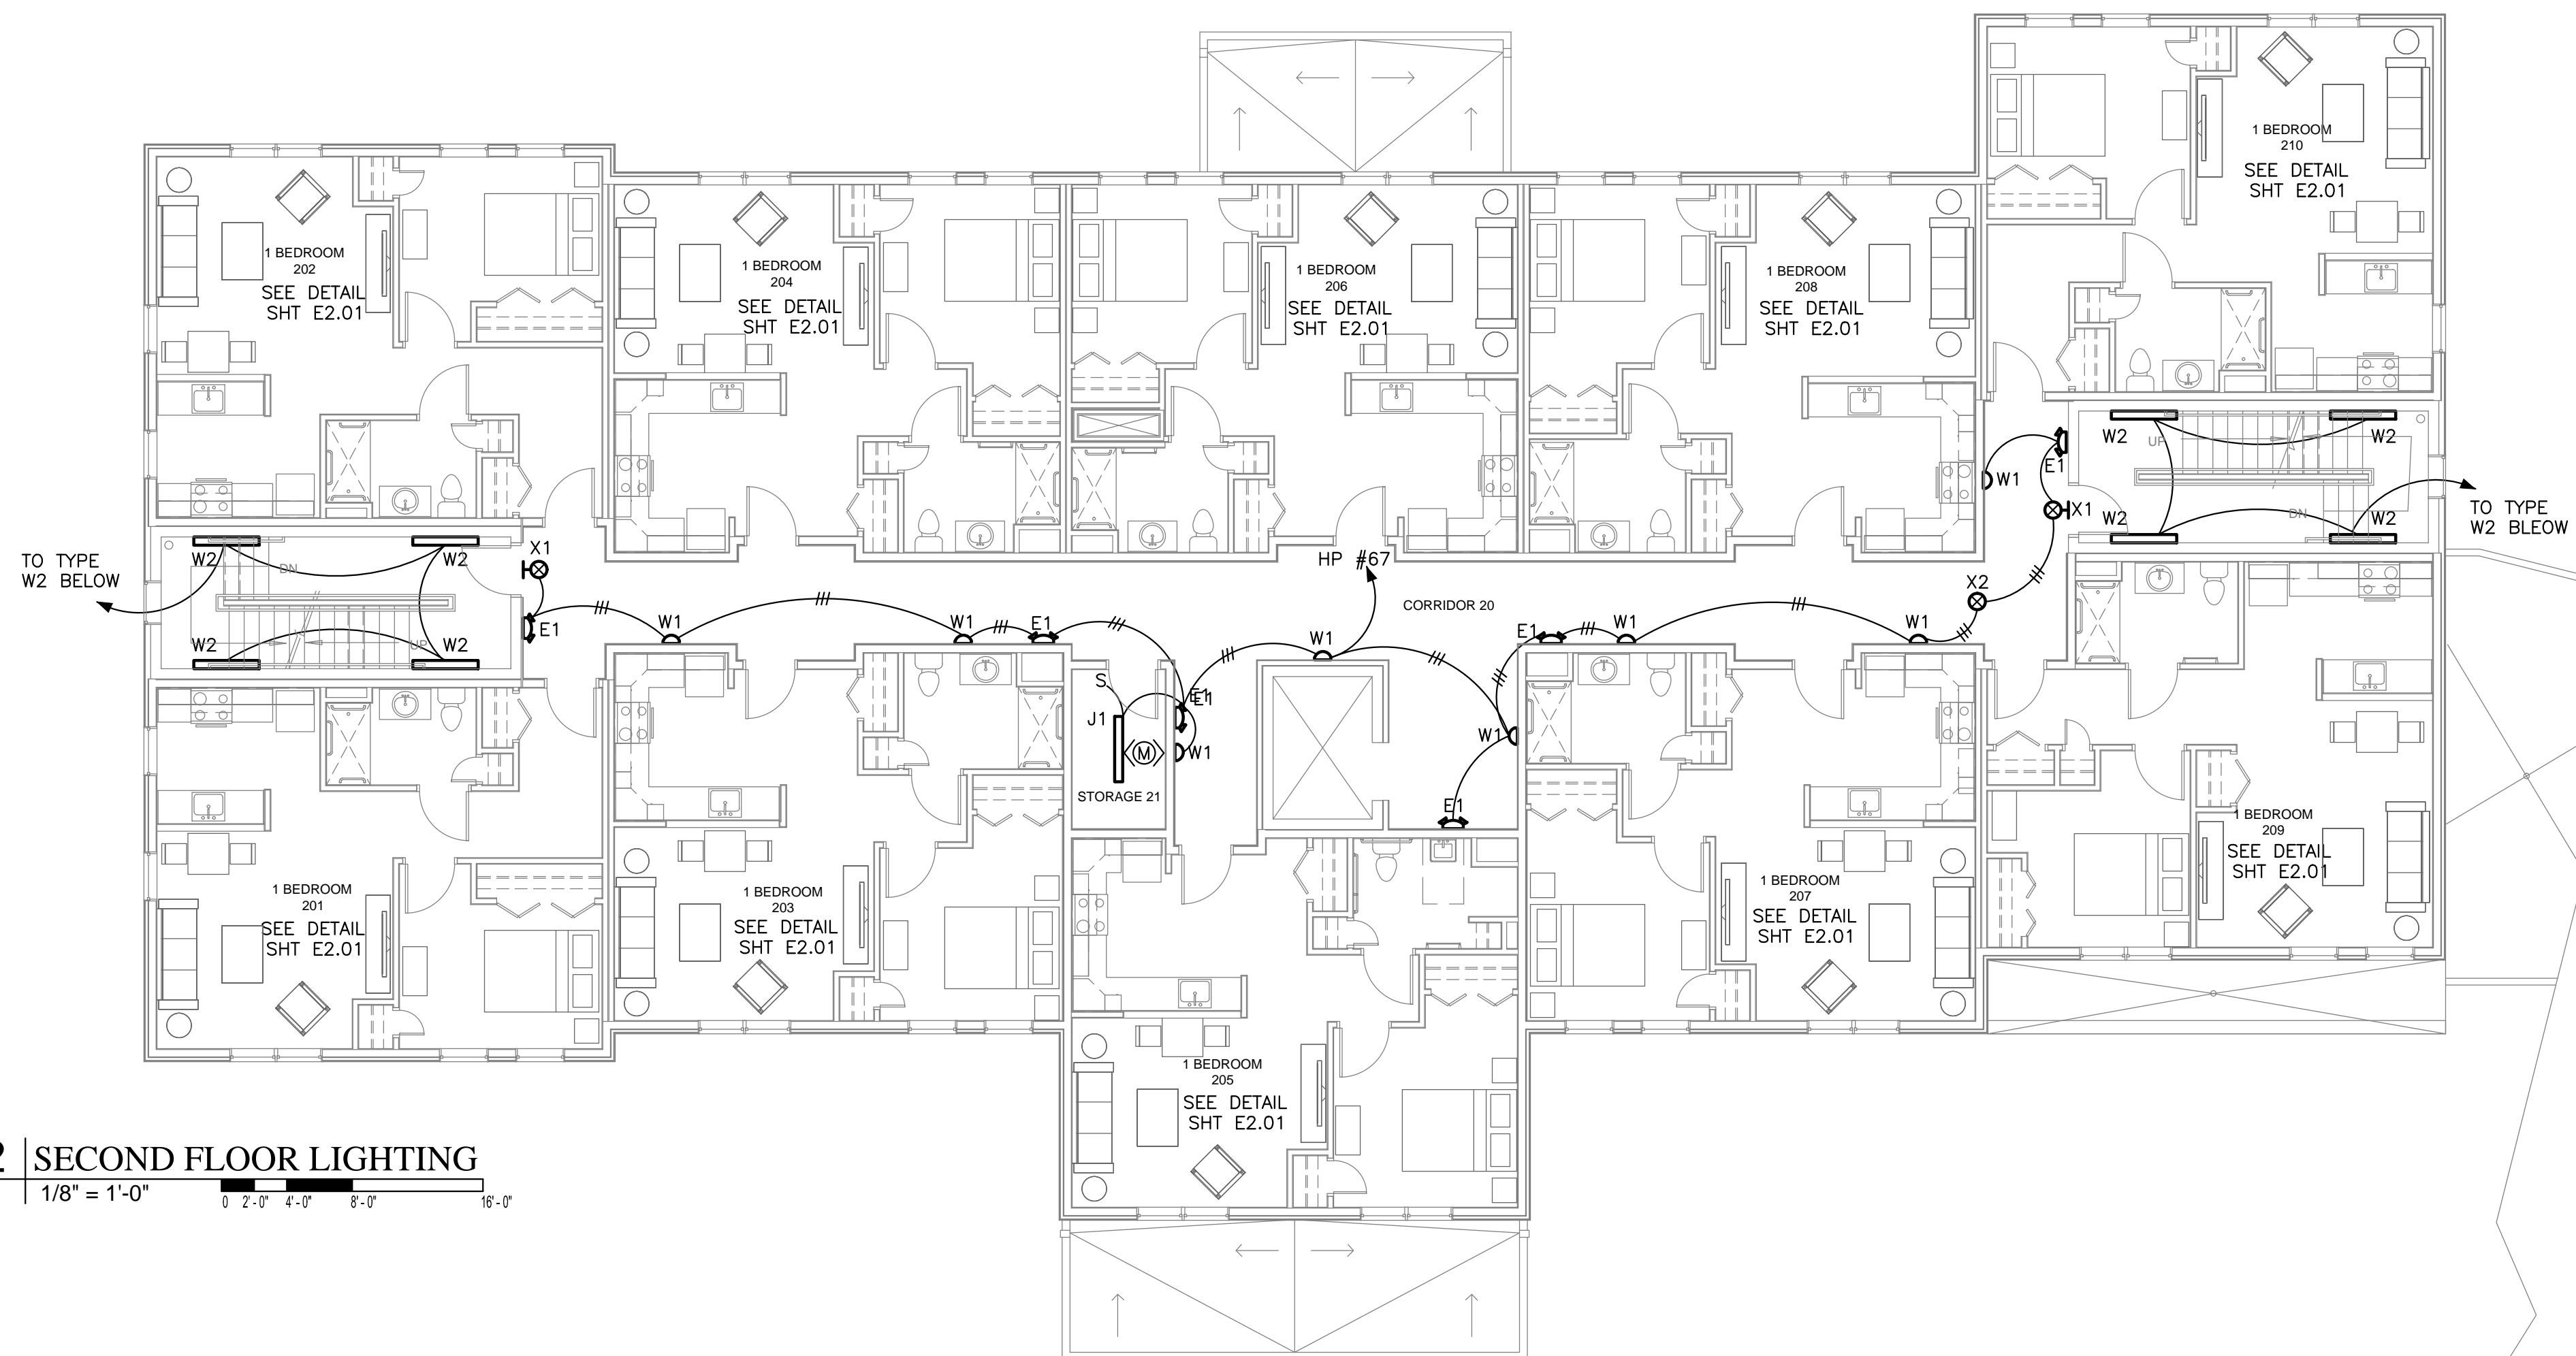

2 SECOND FLOOR LIGHTING
1/8" = 1'-0"

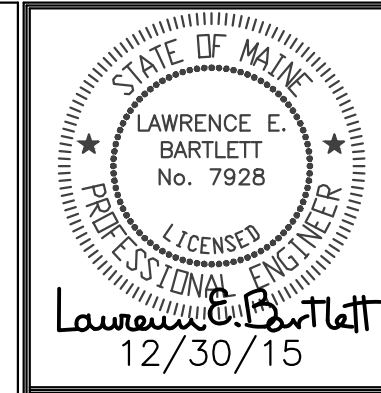

Prepared For:
Westbrook Development Corp. & Millbrook Estates LLP

Consultant:
Bartlett Design
LIGHTING & ELECTRICAL ENGINEERING
48 UNION WHARF, PORTLAND, ME 04101
TEL: (207) 773-6022 FAX: (207) 773-6090

Architect:
ARCHETYPE
Architects
48 Union Wharf Portland, Maine 04101
(207) 773-6022 ARCHETYPE@ARCHETYPEPA.COM

Project:
MILLBROOK ESTATE SENIOR HOUSING
300 East Bridge Street
Westbrook, ME 04092

Revisions:

Date: JAN 04, 2016
Scale: 1/8" = 1'-0"
SECOND FLOOR LIGHTING & POWER PLANS

E1.02

FOR BID